 




1 1ST FLOOR PLAN
SCALE: 3/16" = 1'-0"



NOTE: ACTUAL ROUTE OF CONDUITS WILL BE DETERMINED IN THE FIELD

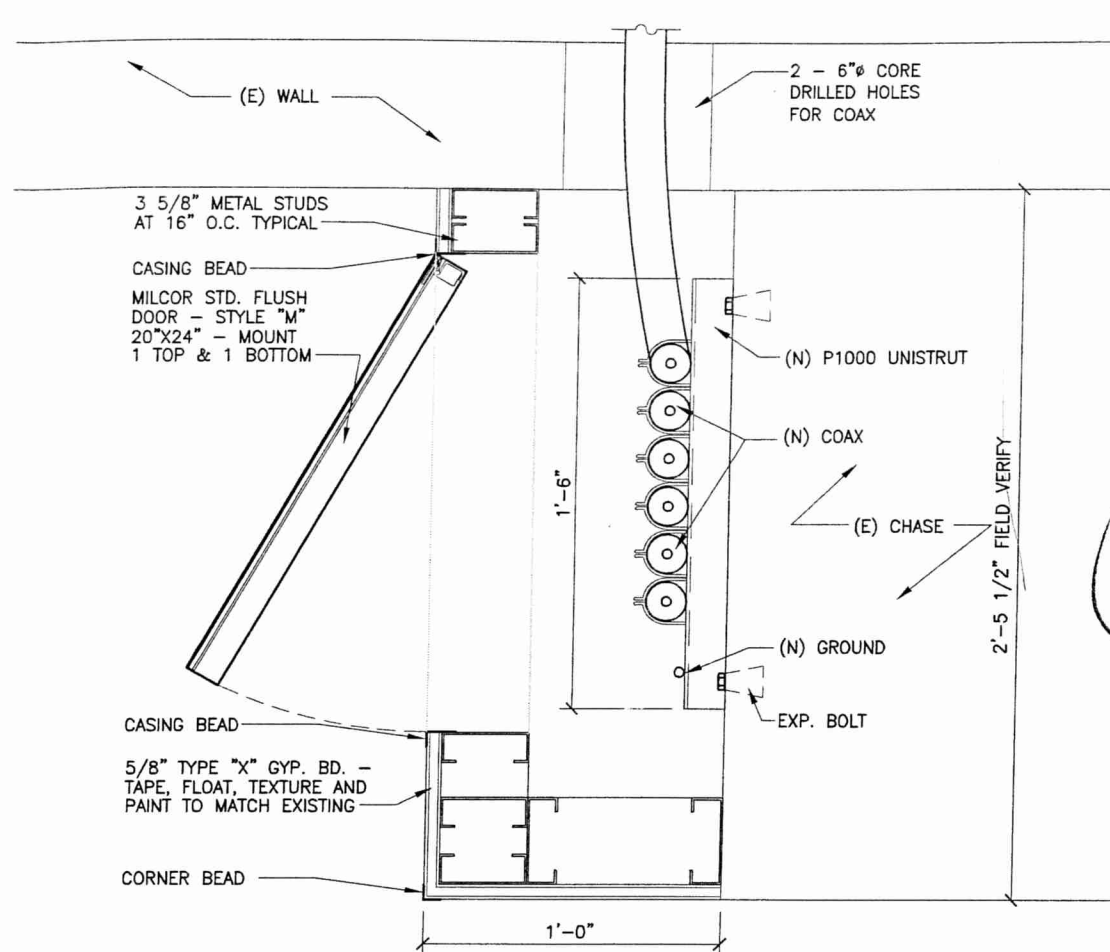

2 PLAN AT COAX CHASE
SCALE: 1 1/2" = 1'-0"

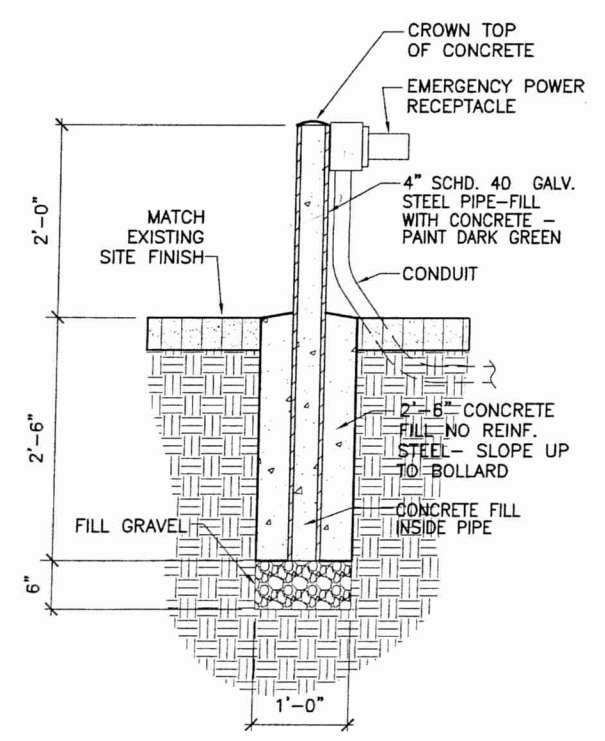

3 EMERGENCY POWER RECEPTACLE MOUNTING
SCALE: 1/2" = 1'-0"




ArchComm Design, Inc. Architects
1840 Lockhill-Selma, Suite 101
San Antonio, Texas 78213
(210)308-9905

DATE: OCT 28 2005



EXP. DATE: 02/28/06

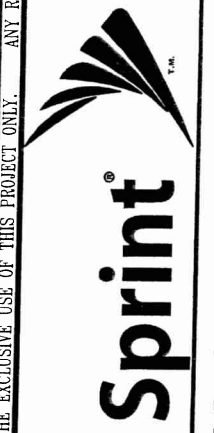

CHURCH OF THE REDEEMER
HO70XC883B
4411 2/3 DALLAS STREET, HOUSTON, TX 77023 (911 ADDRESS)

SHEET TITLE	
1ST FLOOR PLAN	
SHEET HISTORY	
10.28.05	ISSUE FOR CONSTRUCTION
1.	
2.	
3.	
4.	
A2	
SA055053	

THESE DRAWINGS ARE THE PROPERTY OF SPRINT PCS. THEY ARE INTENDED FOR THE EXCLUSIVE USE OF THIS PROJECT ONLY. ANY RE-USE OF THESE PLANS (DRAWINGS) WITHOUT THE EXPRESS WRITTEN CONSENT OF SPRINT PCS IS PROHIBITED.

F:\Sprint\Church of the Redeemer-SA055053-HO70XC883B\BASE DRAWING.dwg, 10/27/2005 8:10:44 AM, jmerdez