




ArchComm Design, Inc. Architects
 1840 Lockhill-Selma, Suite 101
 San Antonio, Texas 78213
 (210)308-9905



THESE DRAWINGS ARE THE PROPERTY OF SPRINT PCS. THEY ARE INTENDED FOR THE EXCLUSIVE USE OF THIS PROJECT ONLY. ANY RE-USE OF THESE PLANS (DRAWINGS) WITHOUT THE EXPRESS WRITTEN CONSENT OF SPRINT PCS IS PROHIBITED.

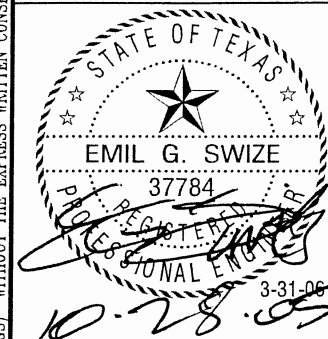

CHURCH OF THE REDEEMER
 HO70XC883B
 4411 DALLAS STREET, HOUSTON, TX 77389

SHEET TITLE
2ND FLOOR ELECTRICAL PLAN

SHEET HISTORY

DATE: 10/28/05

- 1.
- 2.
- 3.
- 4.

E3

SA055068


ESA Emil G. Swize & Associates, Inc.

MECHANICAL & ELECTRICAL ENGINEERING
 1901 N.W. Military Hwy., Suite 201
 San Antonio, Texas 78213 210-342-3483

JOB NO.: 05001"AI"

GENERAL NOTE:

1. X-RAY ALL SLABS BEFORE CORE DRILLING.
2. FIRE SEAL ALL CONDUIT PENETRATIONS THROUGH WALLS AND FLOORS.

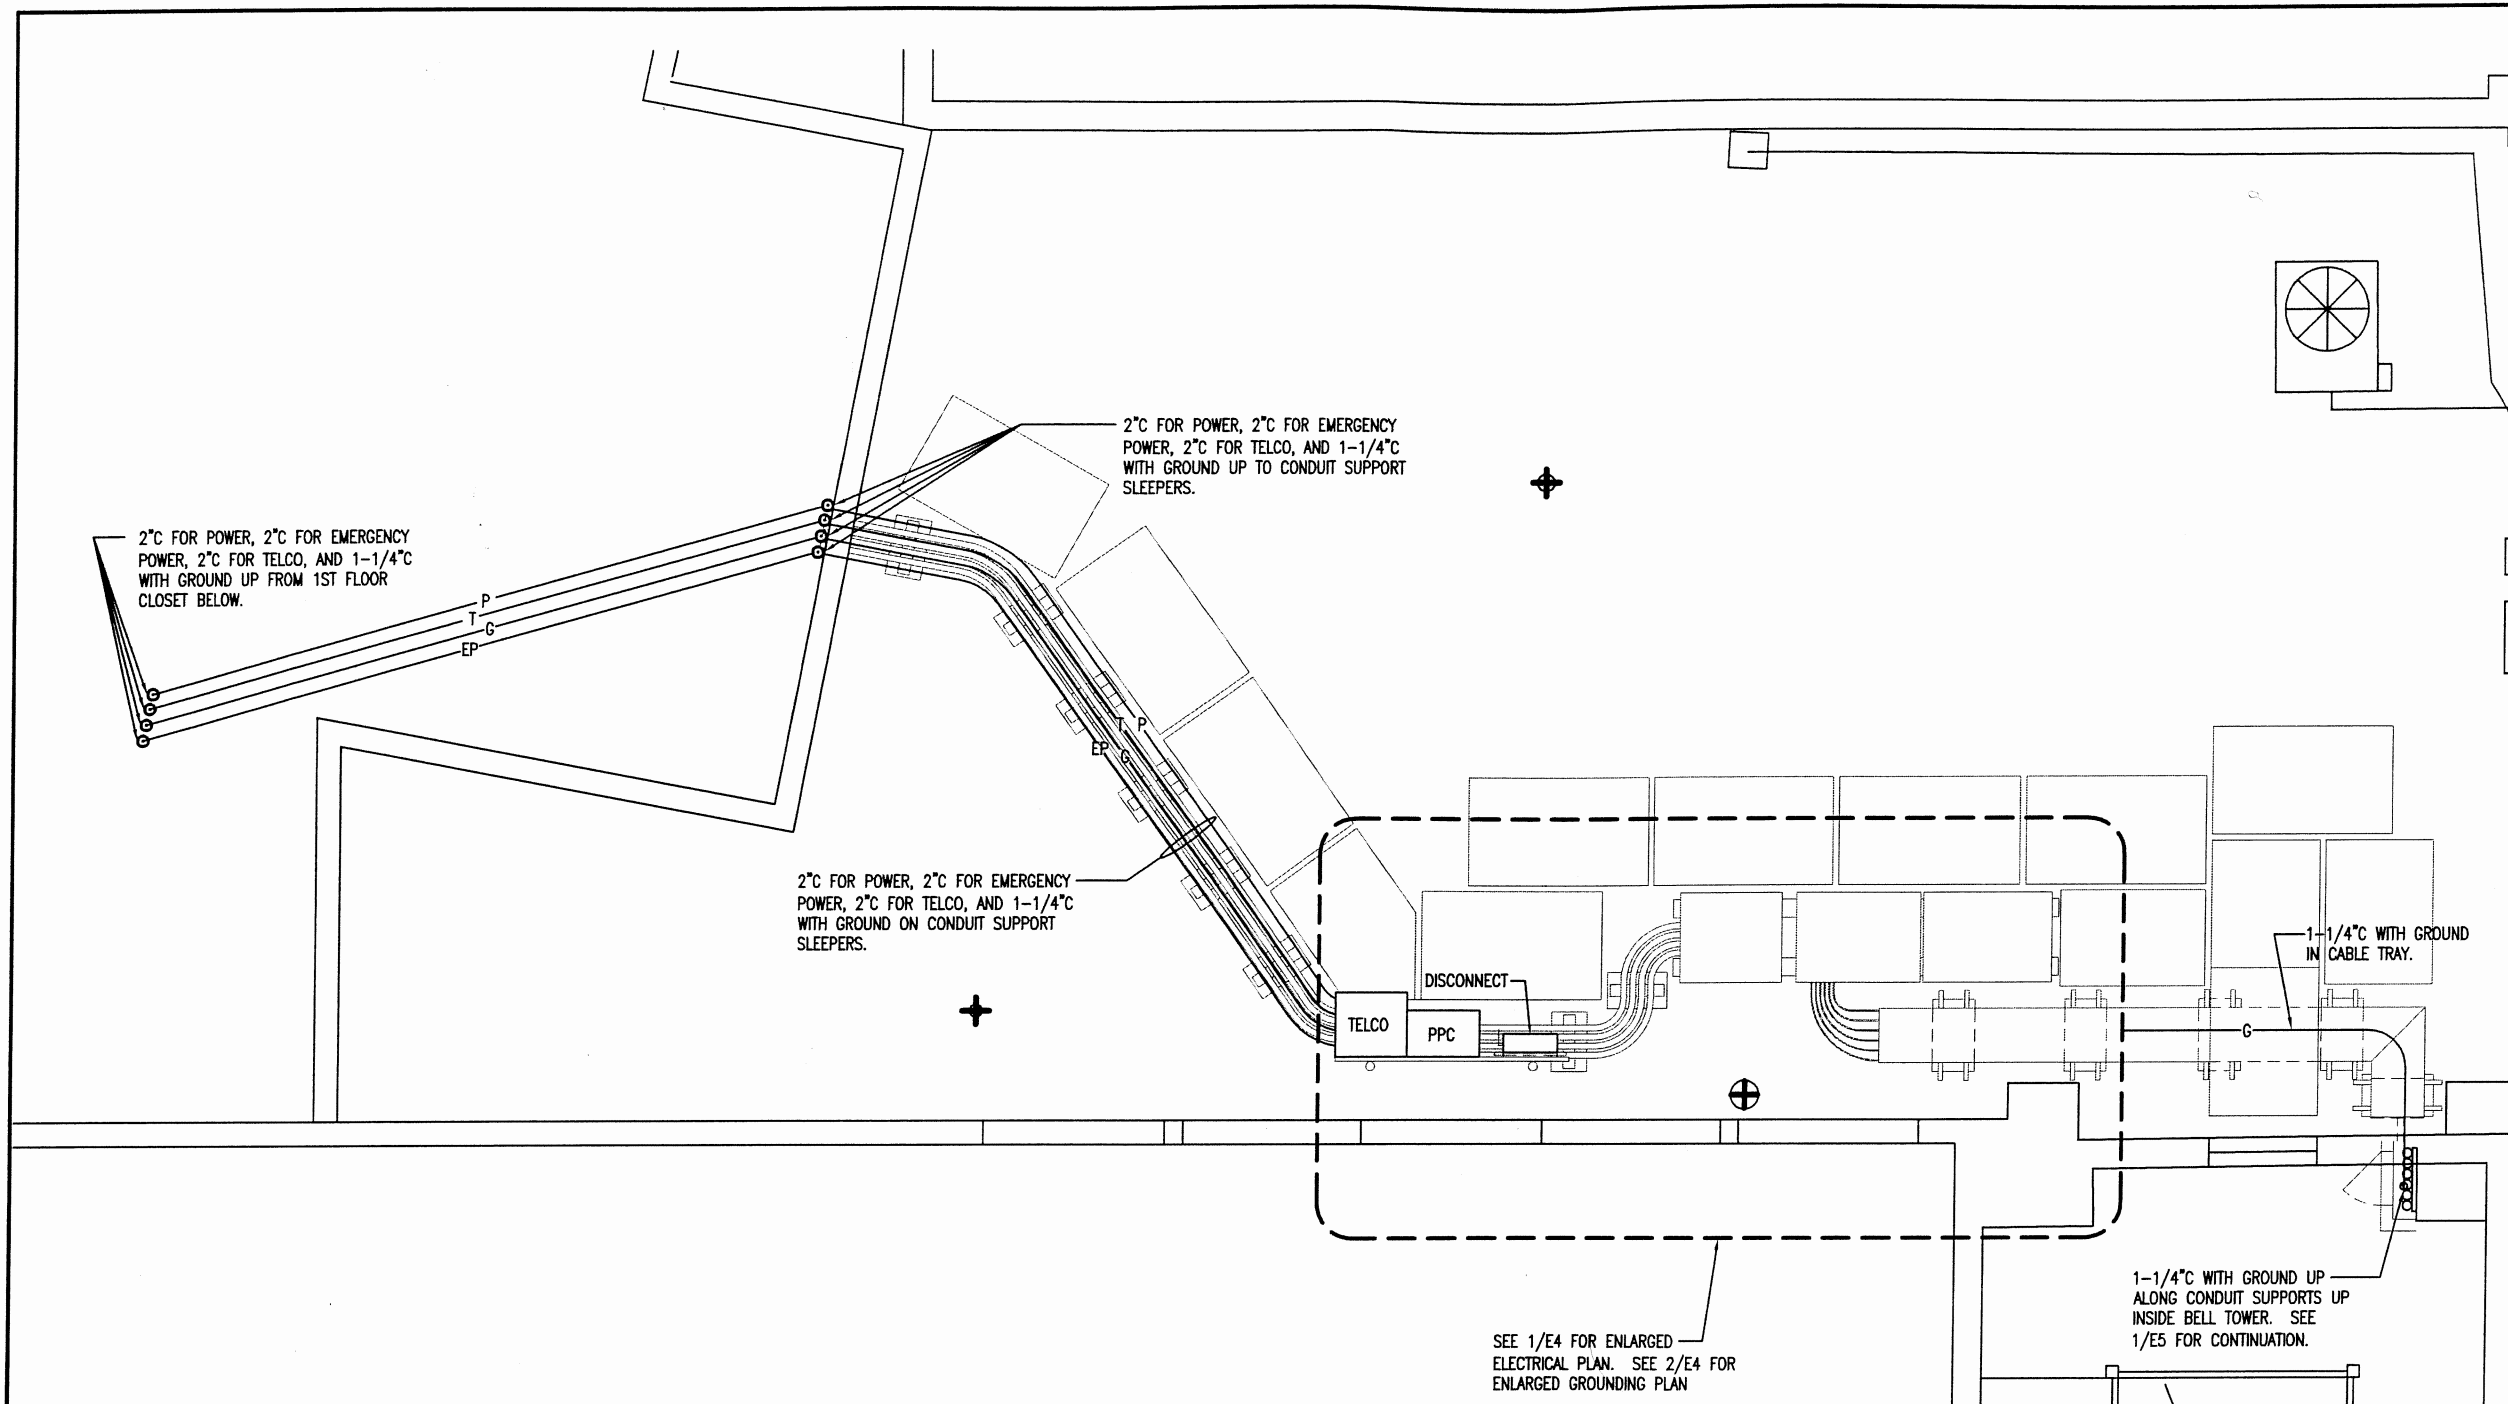

1 2ND FLOOR ELECTRICAL PLAN
 SCALE: 1"=20'-0"

