


1 ENLARGED PLATFORM ELECTRICAL PLAN
SCALE: 1"=20'-0"

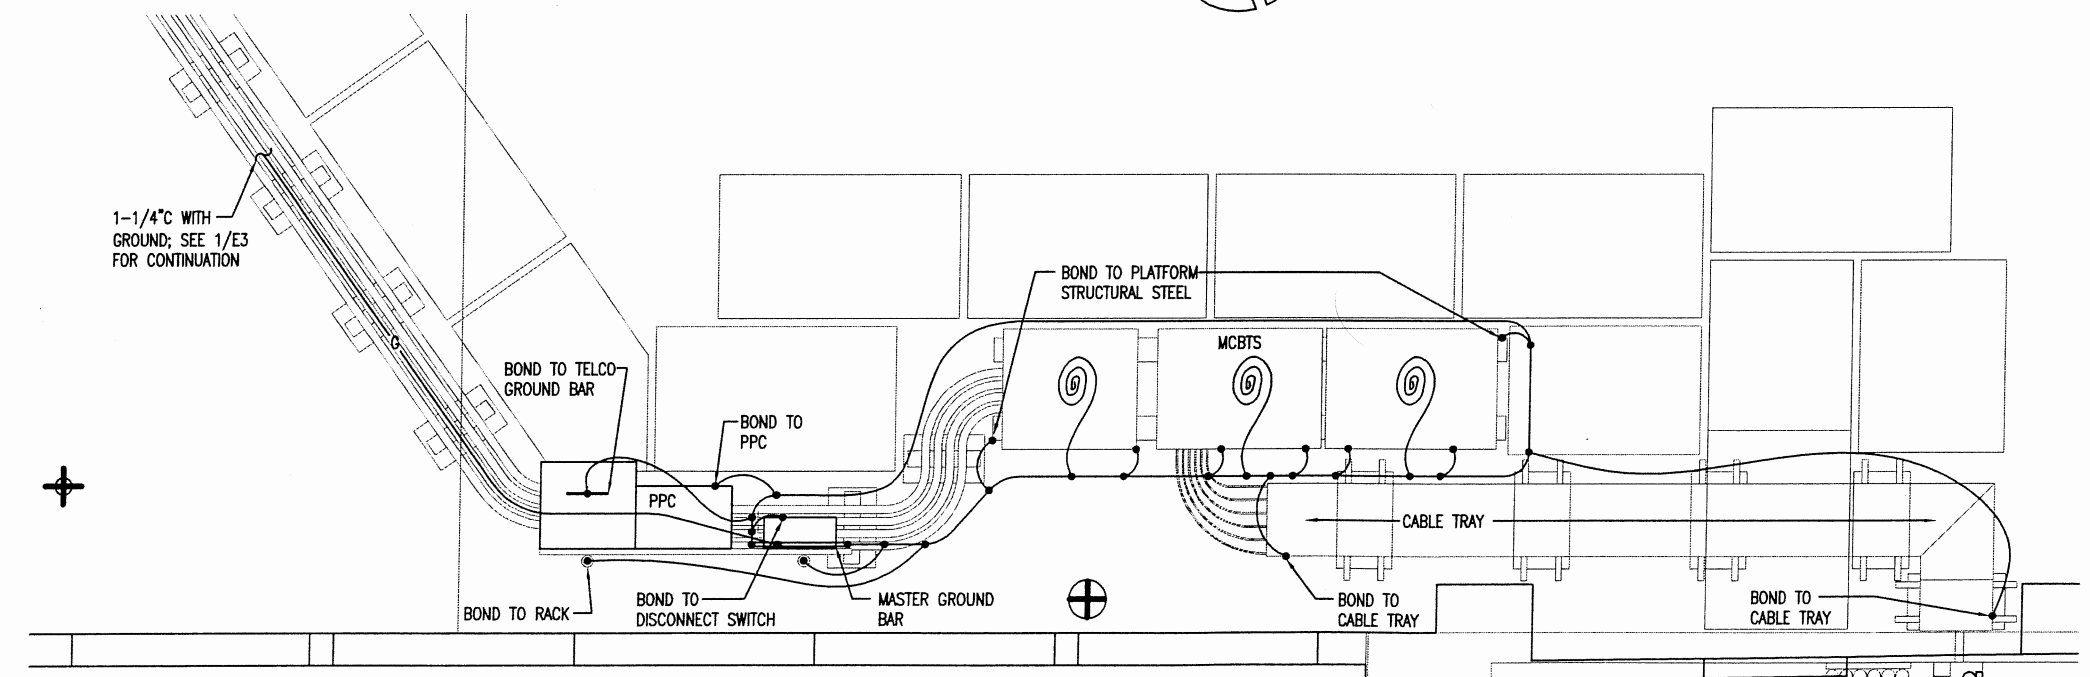


2 ENLARGED PLATFORM GROUNDING PLAN
SCALE: 1"=20'-0"

- GENERAL NOTE:
- X-RAY ALL SLABS BEFORE CORE DRILLING.
 - FIRE SEAL ALL CONDUIT PENETRATIONS THROUGH WALLS AND FLOORS.

ESA Emil G. Swize & Associates, Inc.
MECHANICAL & ELECTRICAL ENGINEERING
1901 N.W. Military Hwy., Suite 201
San Antonio, Texas 78213 210-342-3483
JOB NO.: 05001"AI"



ArchComm Design, Inc. Architects
1840 Lockhill-Selma, Suite 101
San Antonio, Texas 78213
(210)308-9905

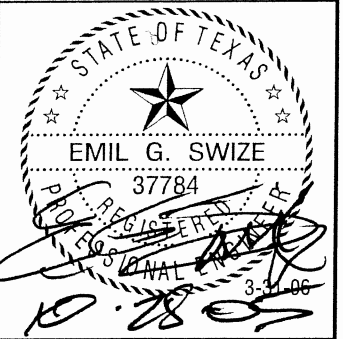

CHURCH OF THE REDEEMER
HO70XC883B
4411 DALLAS STREET, HOUSTON, TX 77389

SHEET TITLE
2ND FLOOR ELECTRICAL PLAN

SHEET HISTORY
DATE: 10/28/05

-
-
-
-

E4

SA055068

THESE DRAWINGS ARE THE PROPERTY OF SPRINT PCS. THEY ARE INTENDED FOR THE EXCLUSIVE USE OF THIS PROJECT ONLY. ANY RE-USE OF THESE PLANS (DRAWINGS) WITHOUT THE EXPRESS WRITTEN CONSENT OF SPRINT PCS IS PROHIBITED.